




SECTION AA
 (Scale 1:100)

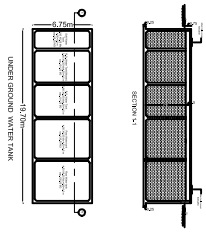


SECTION AA
 UNDER GROUND WATER TANK

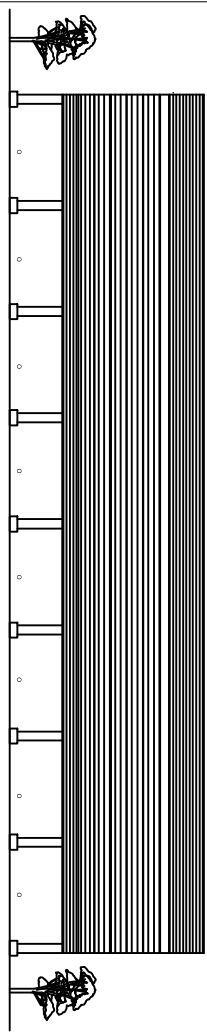


FRONT ELEVATION
 (Scale 1:100)

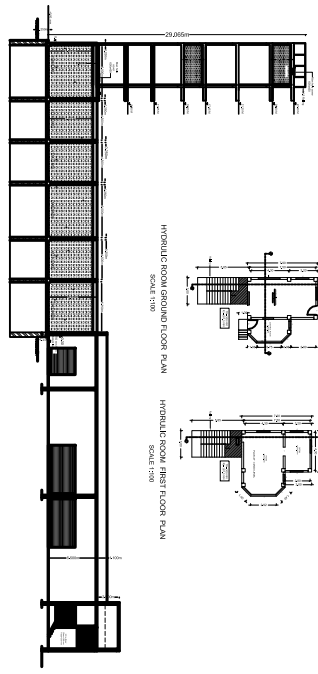


SECTION AA
 (Scale 1:100)

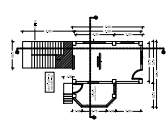


HYDRAULIC ROOM GROUND FLOOR PLAN
 SCALE 1:50

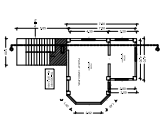


HYDRAULIC ROOM FIRST FLOOR PLAN
 SCALE 1:50

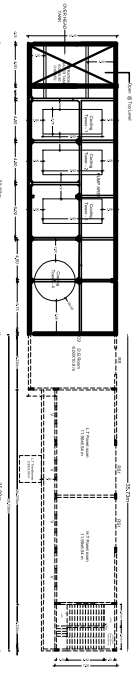




WATER COMPLEX FIRST FLOOR PLAN
 (Scale 1:100)

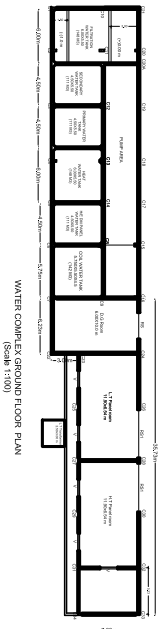

WATER COMPLEX GROUND FLOOR PLAN
 (Scale 1:100)

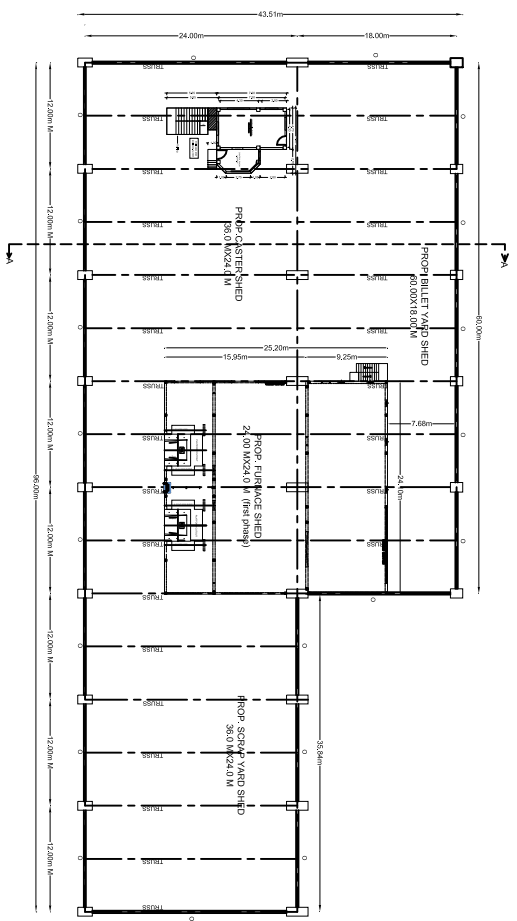

GROUND FLOOR PLAN
 SCALE 1:100

 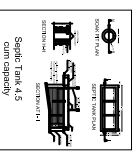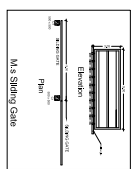

REVISION			
NO.	DESCRIPTION	DATE	BY

NOTES
 1. ALL DIMENSIONS ARE IN METERS UNLESS OTHERWISE SPECIFIED.
 2. ALL WALLS ARE 230MM THICK UNLESS OTHERWISE SPECIFIED.
 3. ALL FLOORS ARE TO BE FINISHED TO THE FINISH LEVEL UNLESS OTHERWISE SPECIFIED.
 4. ALL ROOFS ARE TO BE FINISHED TO THE FINISH LEVEL UNLESS OTHERWISE SPECIFIED.

Name/Stamp and sign for Client

 Name/Stamp and sign for Architect

MS. PANKAJ SHROE AND ASSOCIATES
 (Architect - Student Engineer)
 101, Sector 22, Chandigarh
 Phone: 98765 43210
 Email: info@mspankajshroe.com

Date: 04/07/2019
 Scale: As per dwg
 Dwg. No.: As Per dwg
 Pkg. No.: As Per dwg

NO.	DESCRIPTION	DATE	BY