

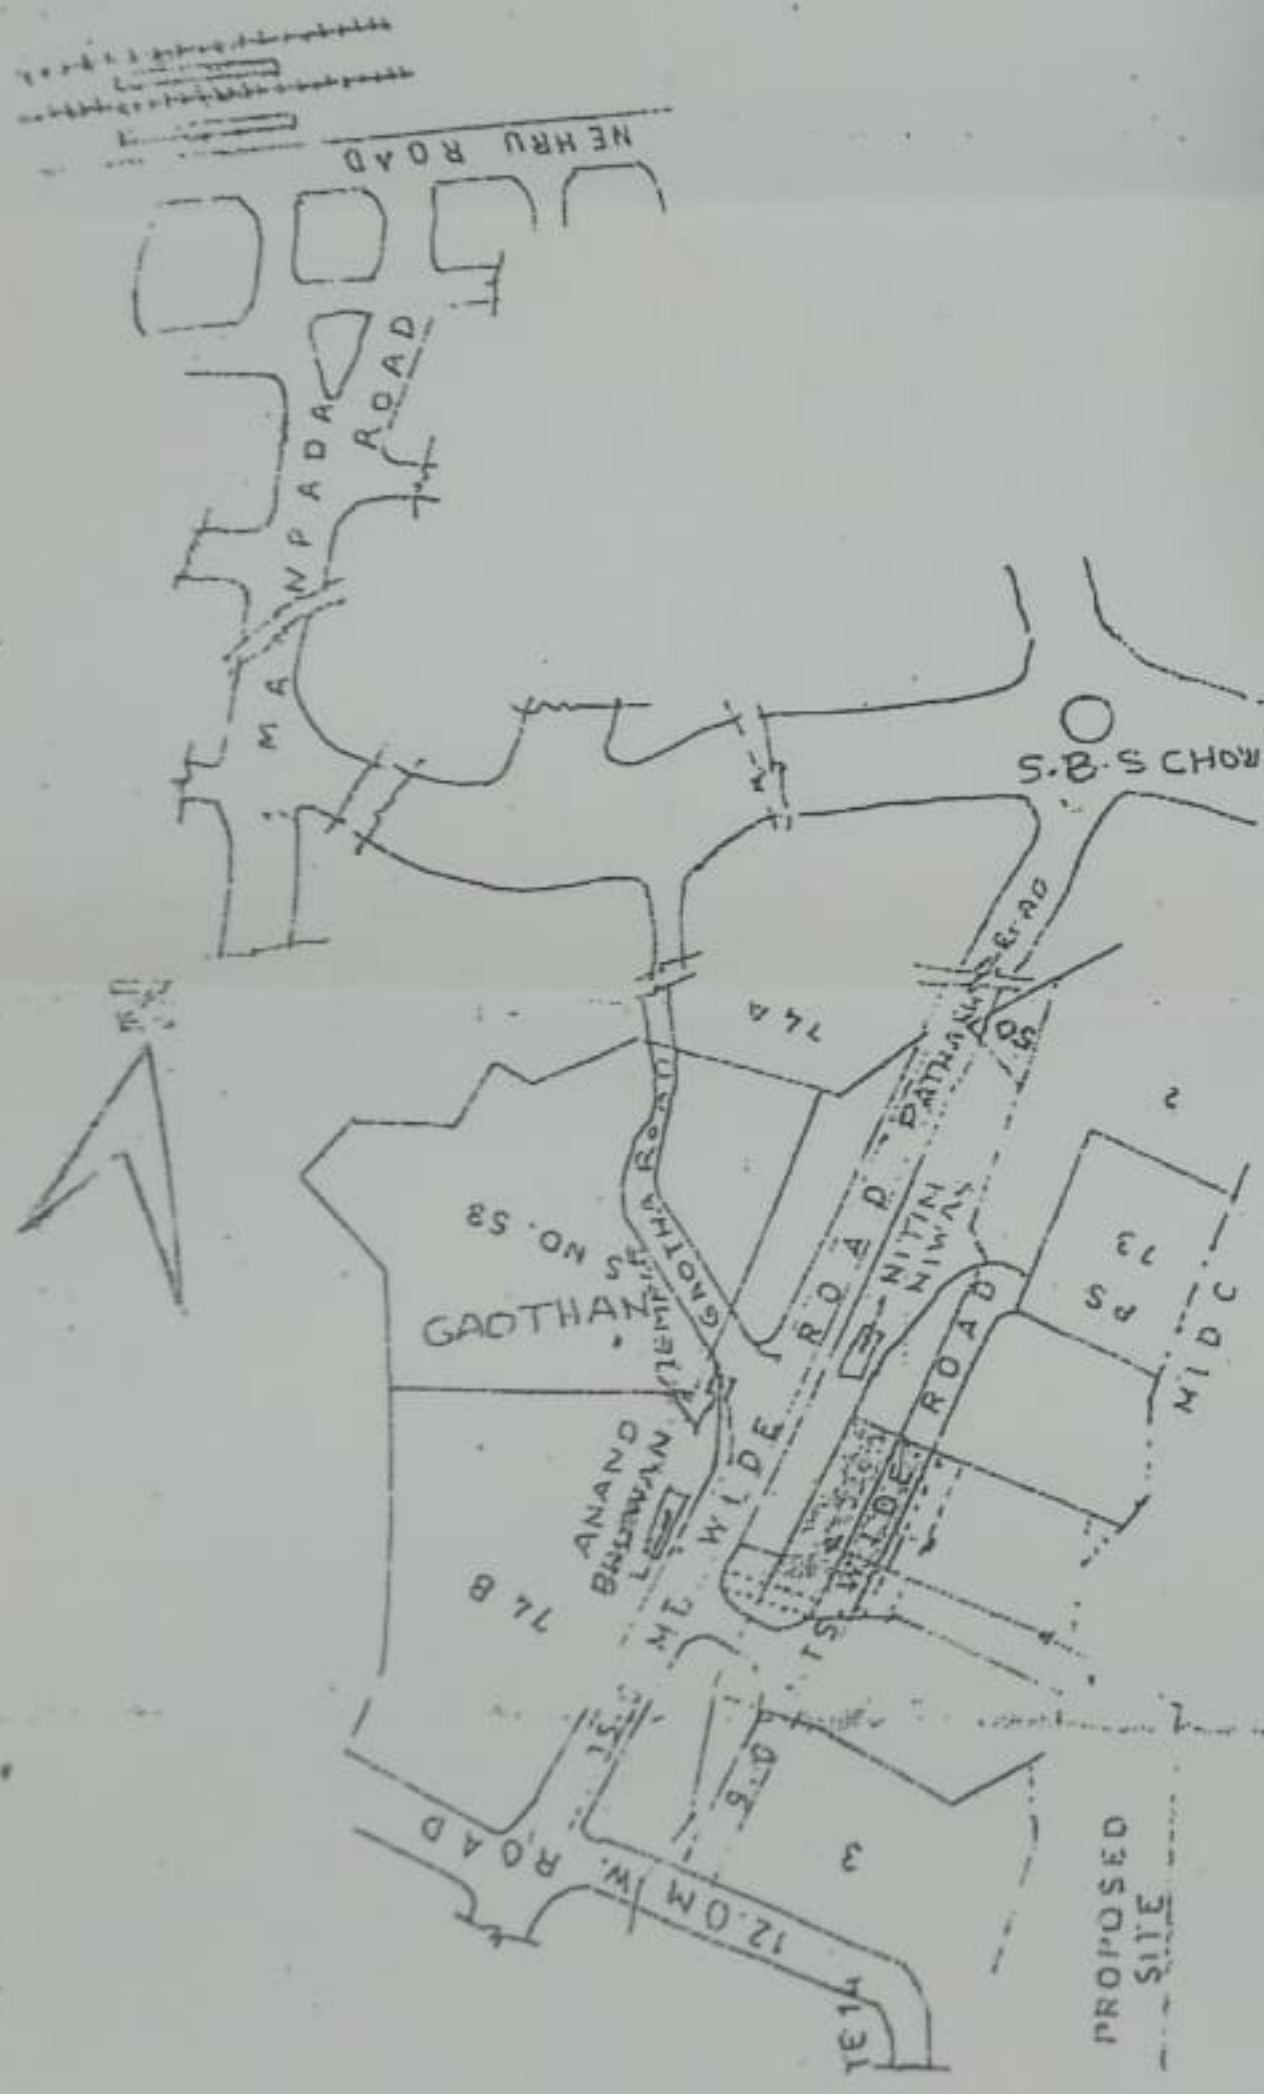


मंजूरी क्र. दि. १३
 डॉ. ल्या. सं. १३
 वास्तुशास्त्र विभाग
 मध्य प्रदेश शासन
 रंगाने दुलसी

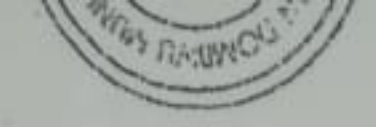

LOCATION PLAN

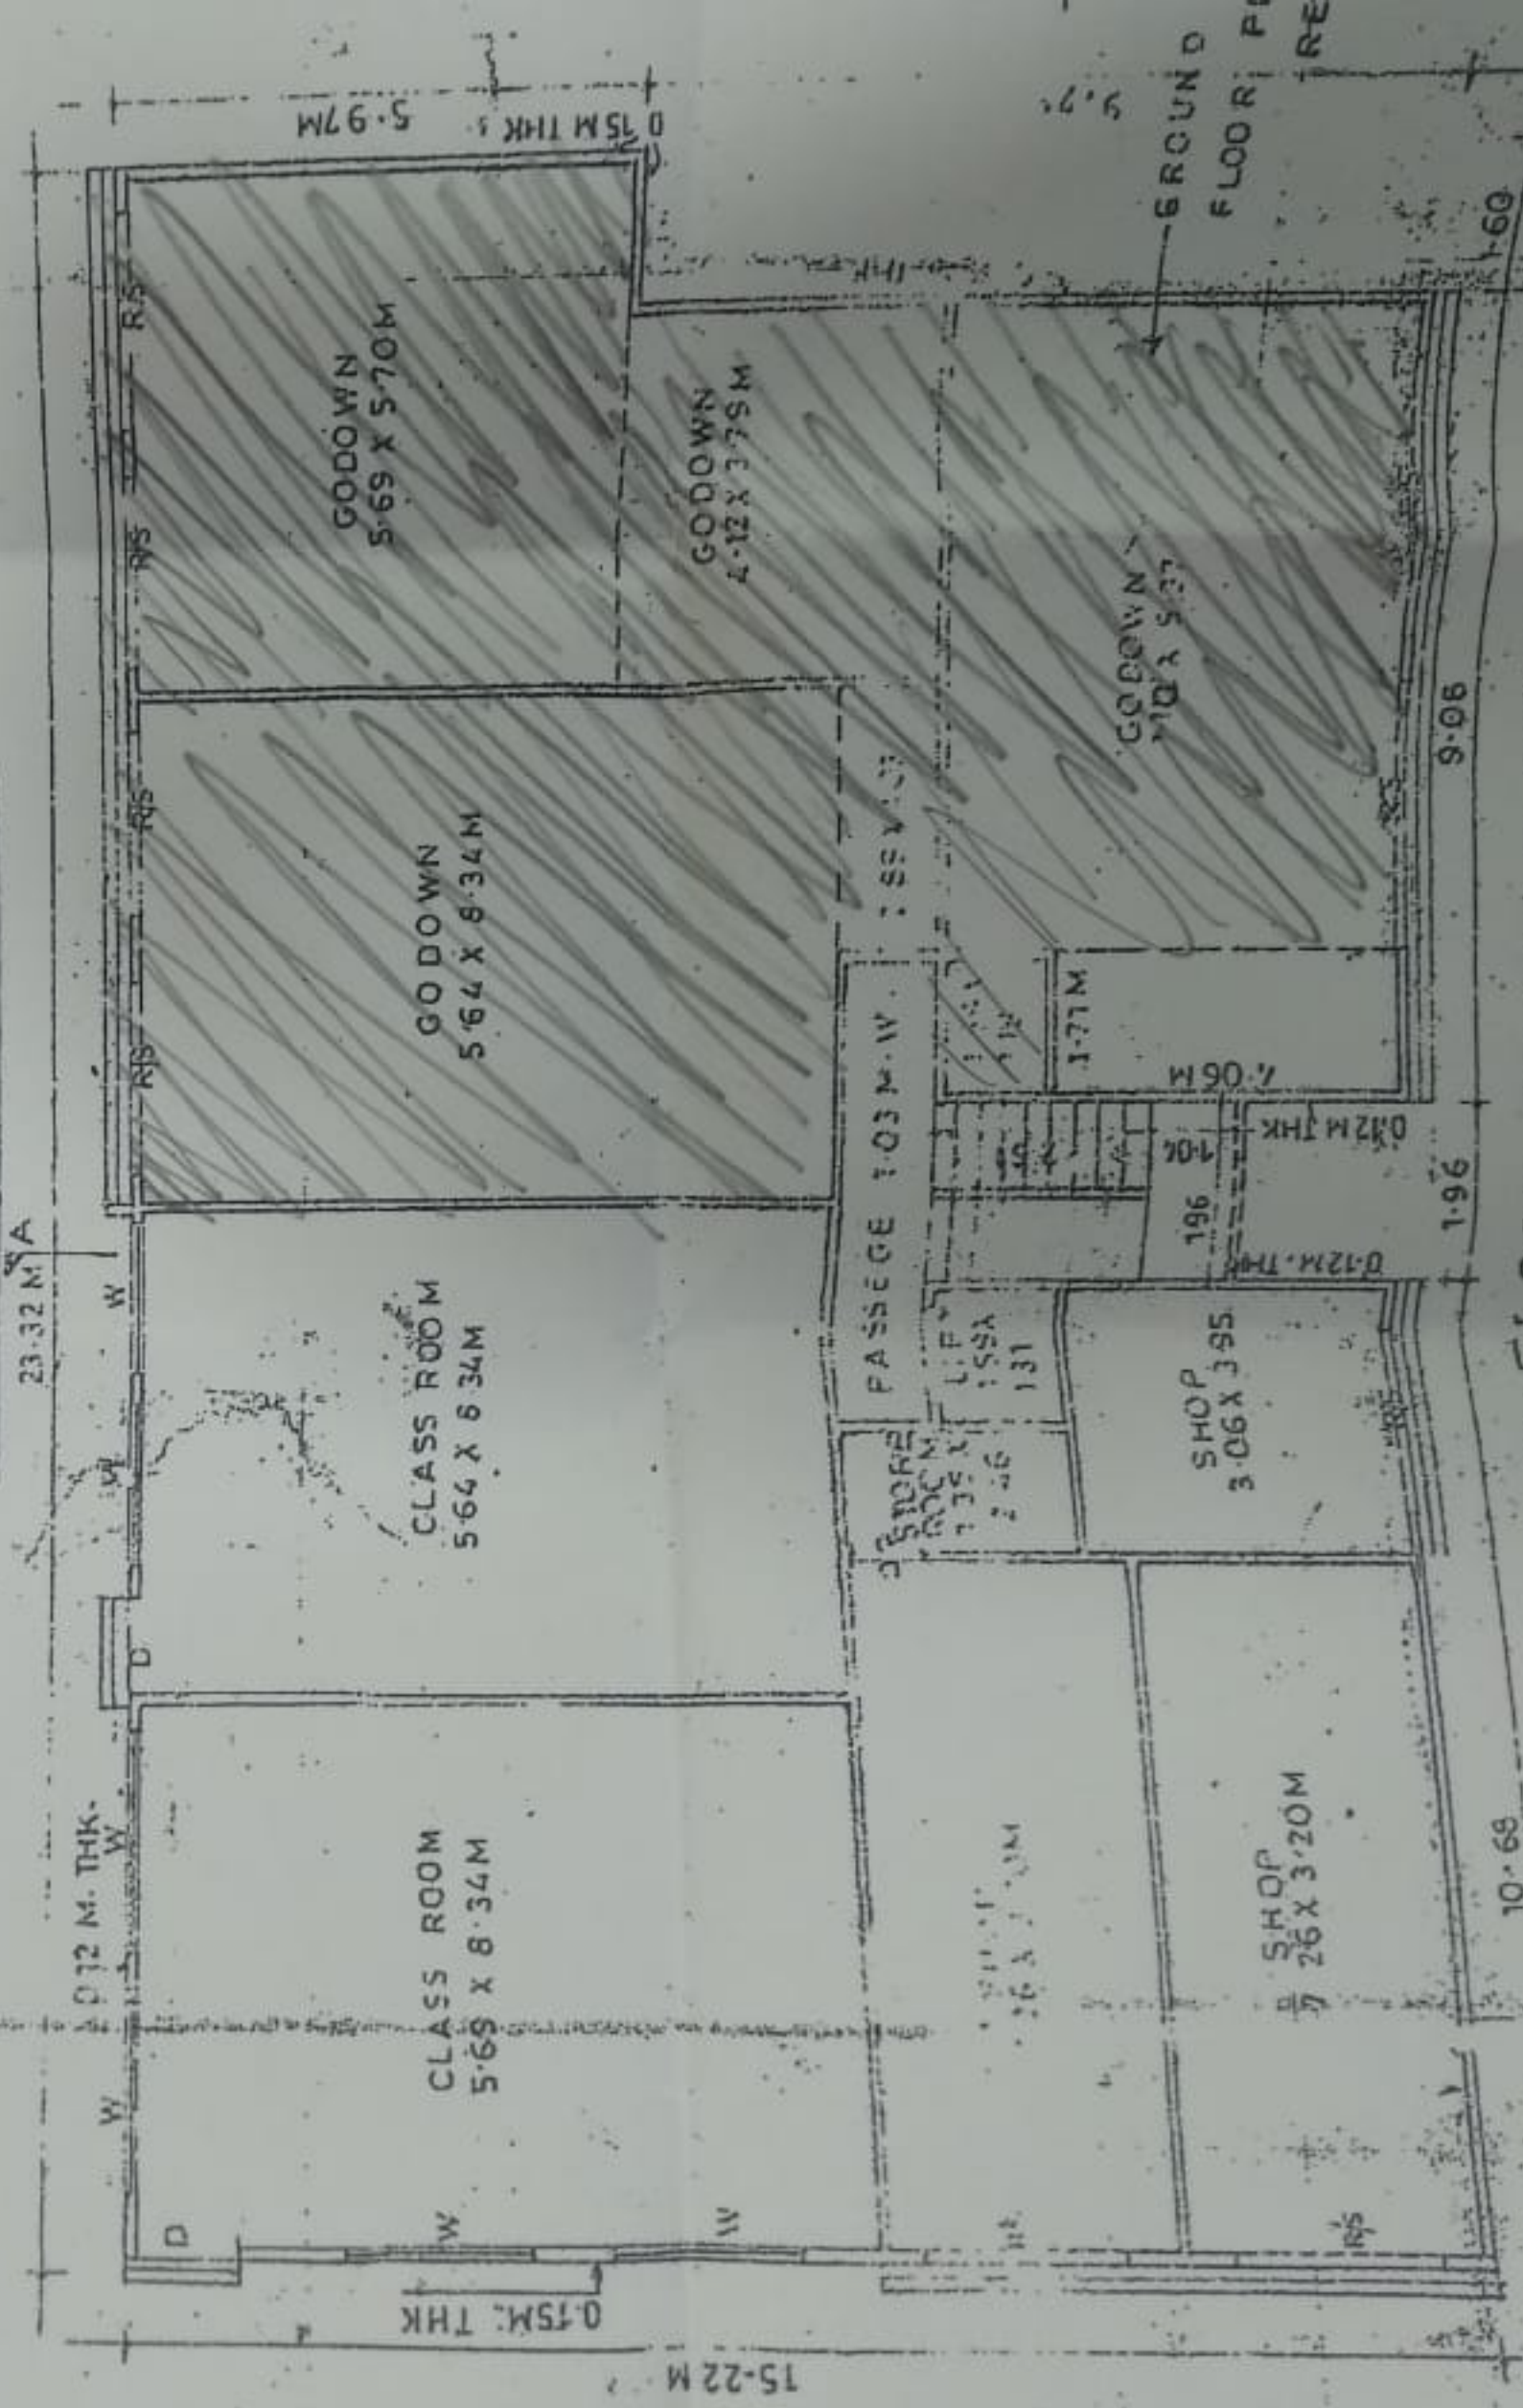


GROUND FLOOR PLAN (BLDNG NO. 1)

SCALE 1:100

R.C.C. SLAB 6" THK

0-10'

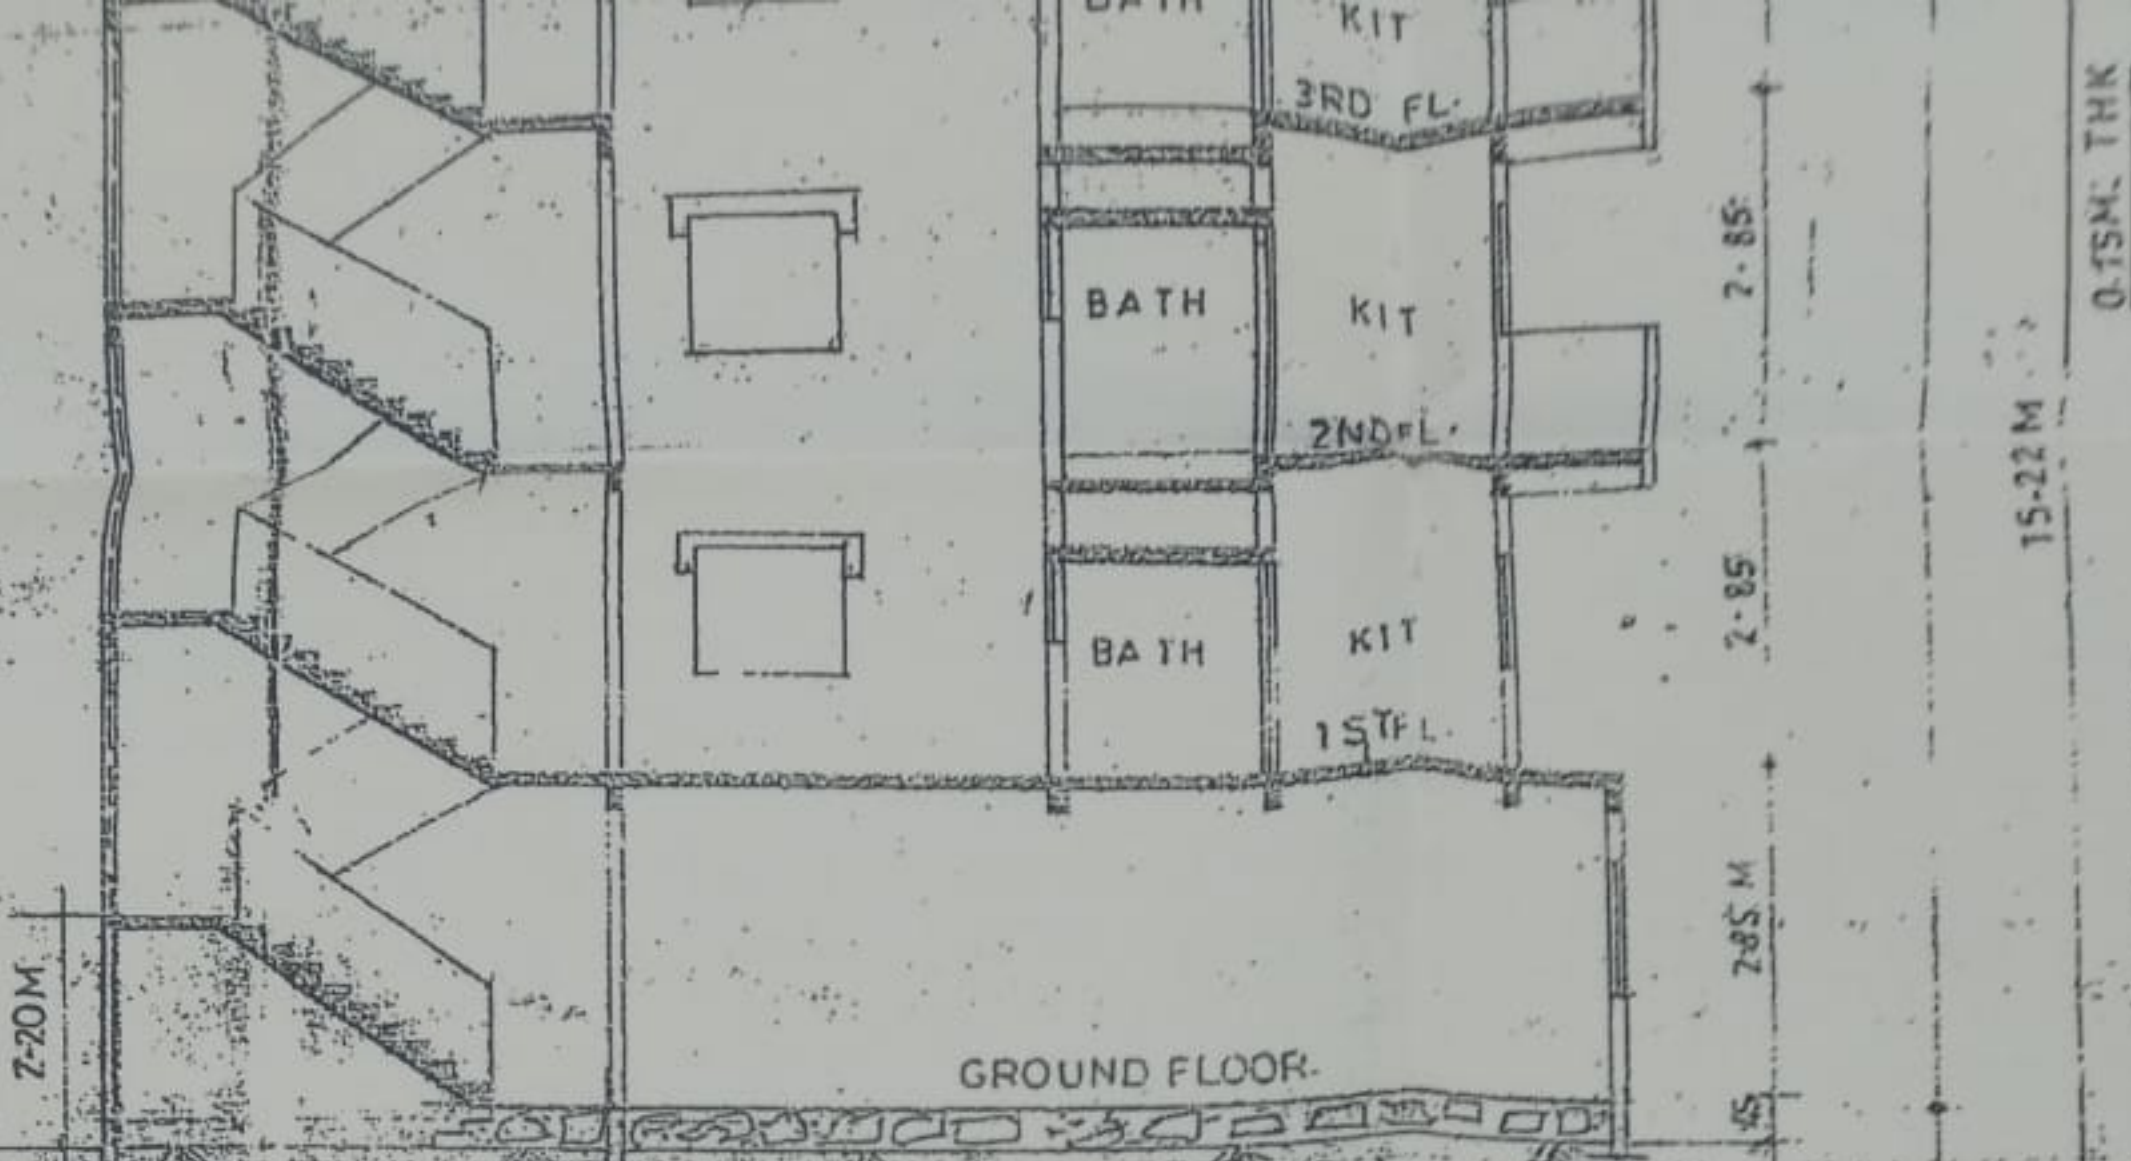


SECTION AT A-A


(BLDG NO-1) SCALE: 1:100

AREA CALCULATION IN SQ. MTS

PLOT AREA IN SQ. MTS		
X 15.30 X 0.50		306.00
X 6.75 X 0.50		160.31
X 28.00 X 0.50		742.00
X 15.00 X 0.50		232.50
X 14.34 X 0.50		164.99
X 12.65 X 0.50		145.28
NET PLOT AREA		1751.28
BACK AREA		
0 X 12.25 X 0.50		131.69
0 X 14.25 X 0.50		153.19
L SET BACK AREA		284.88
PLOT AREA (A+B)		
(28 + 284.88)		2036.16

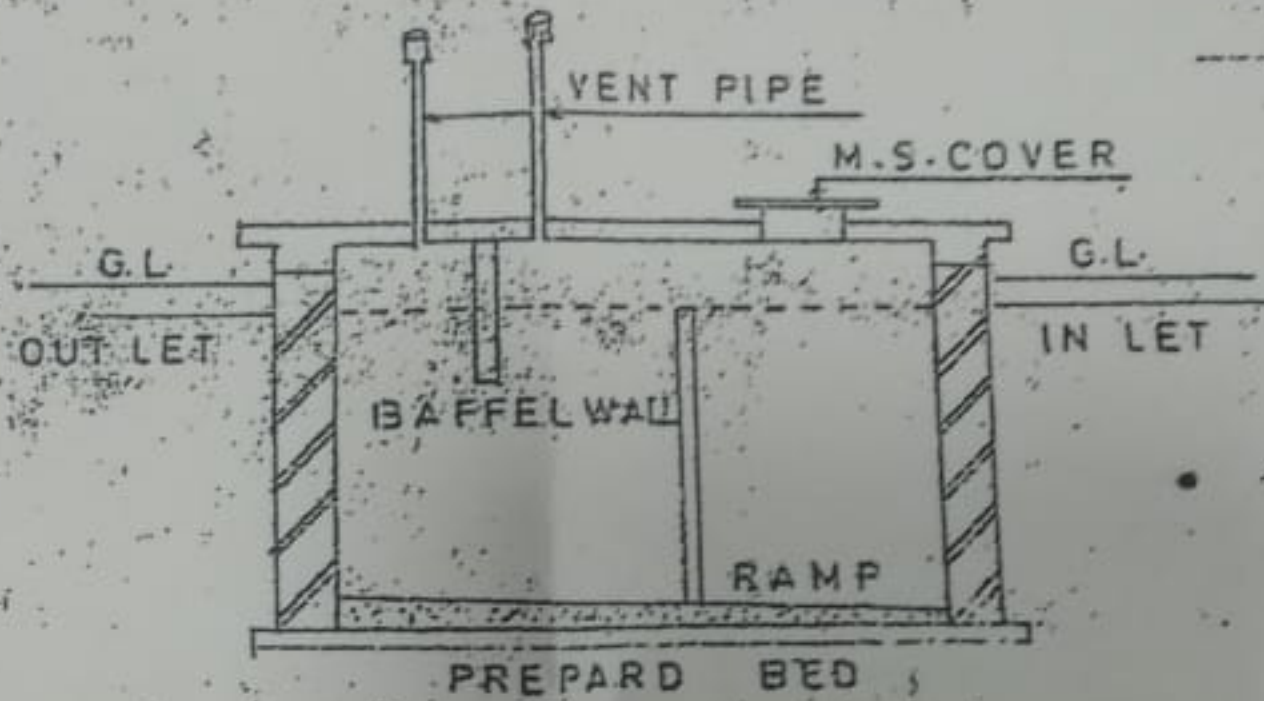


SECTION

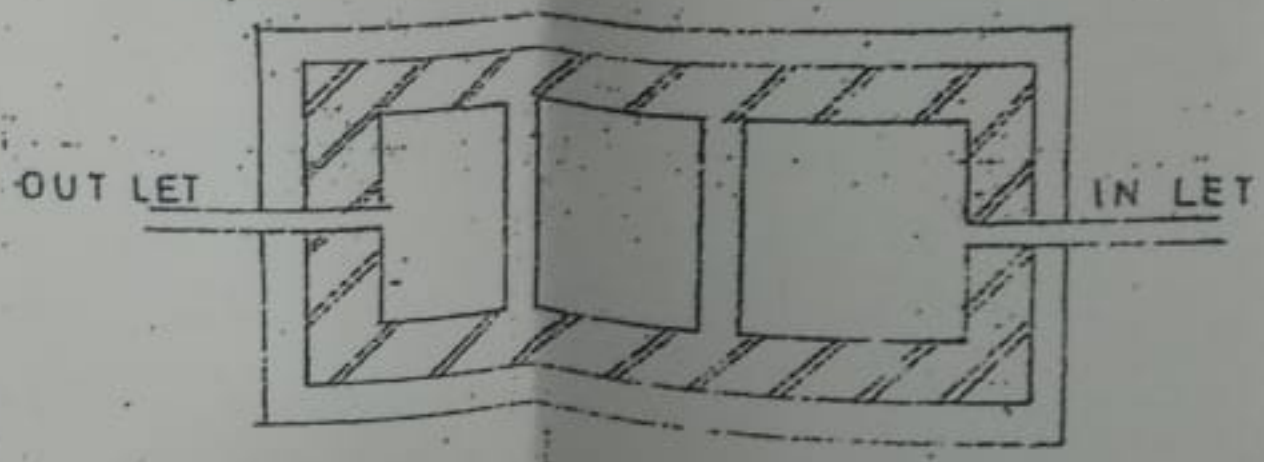

PLAN OF SEPTIC TANK

6-98 M.

O.W. WATER
2.1000
155.45 0.75
RISER 2.000

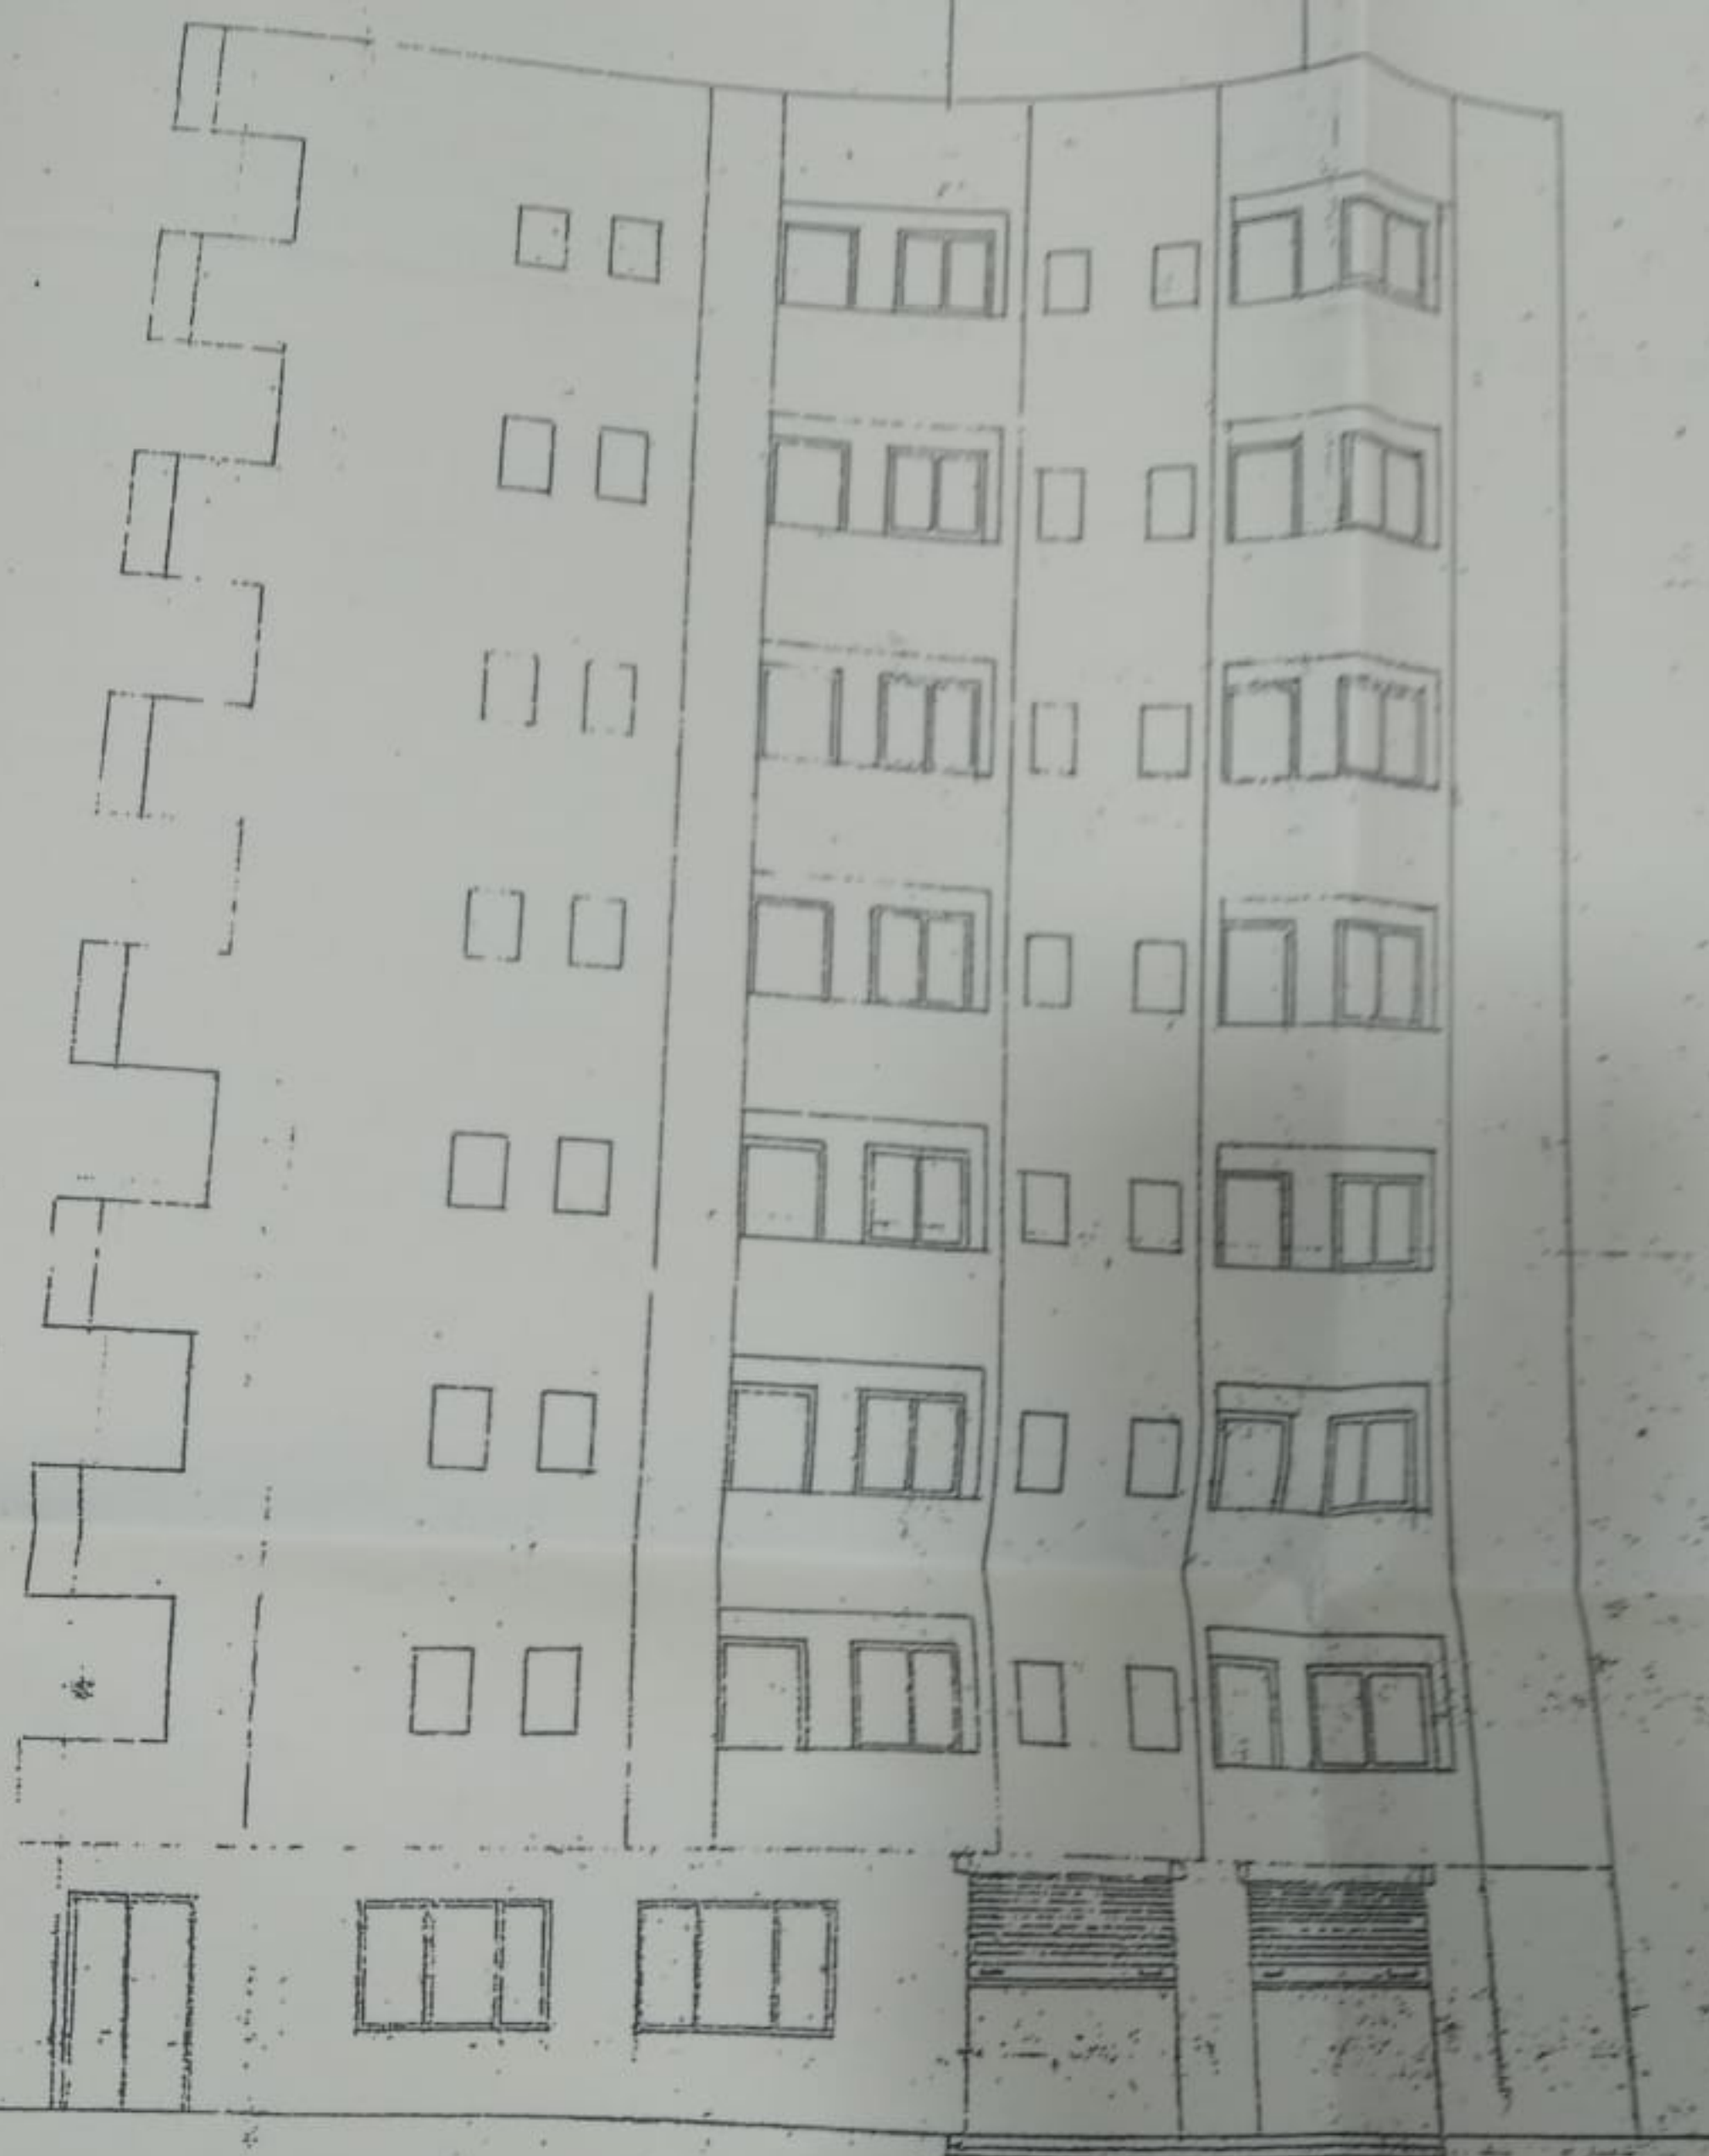


SIDE ELEVATION

BLDG NO-1 (1:100)

2.20M.

THIS BUILDING APPROVED BY KDMC VIDE LETTER NO
KDMC | NRV | BP | DOM / 60-13
DATE 7/5/99

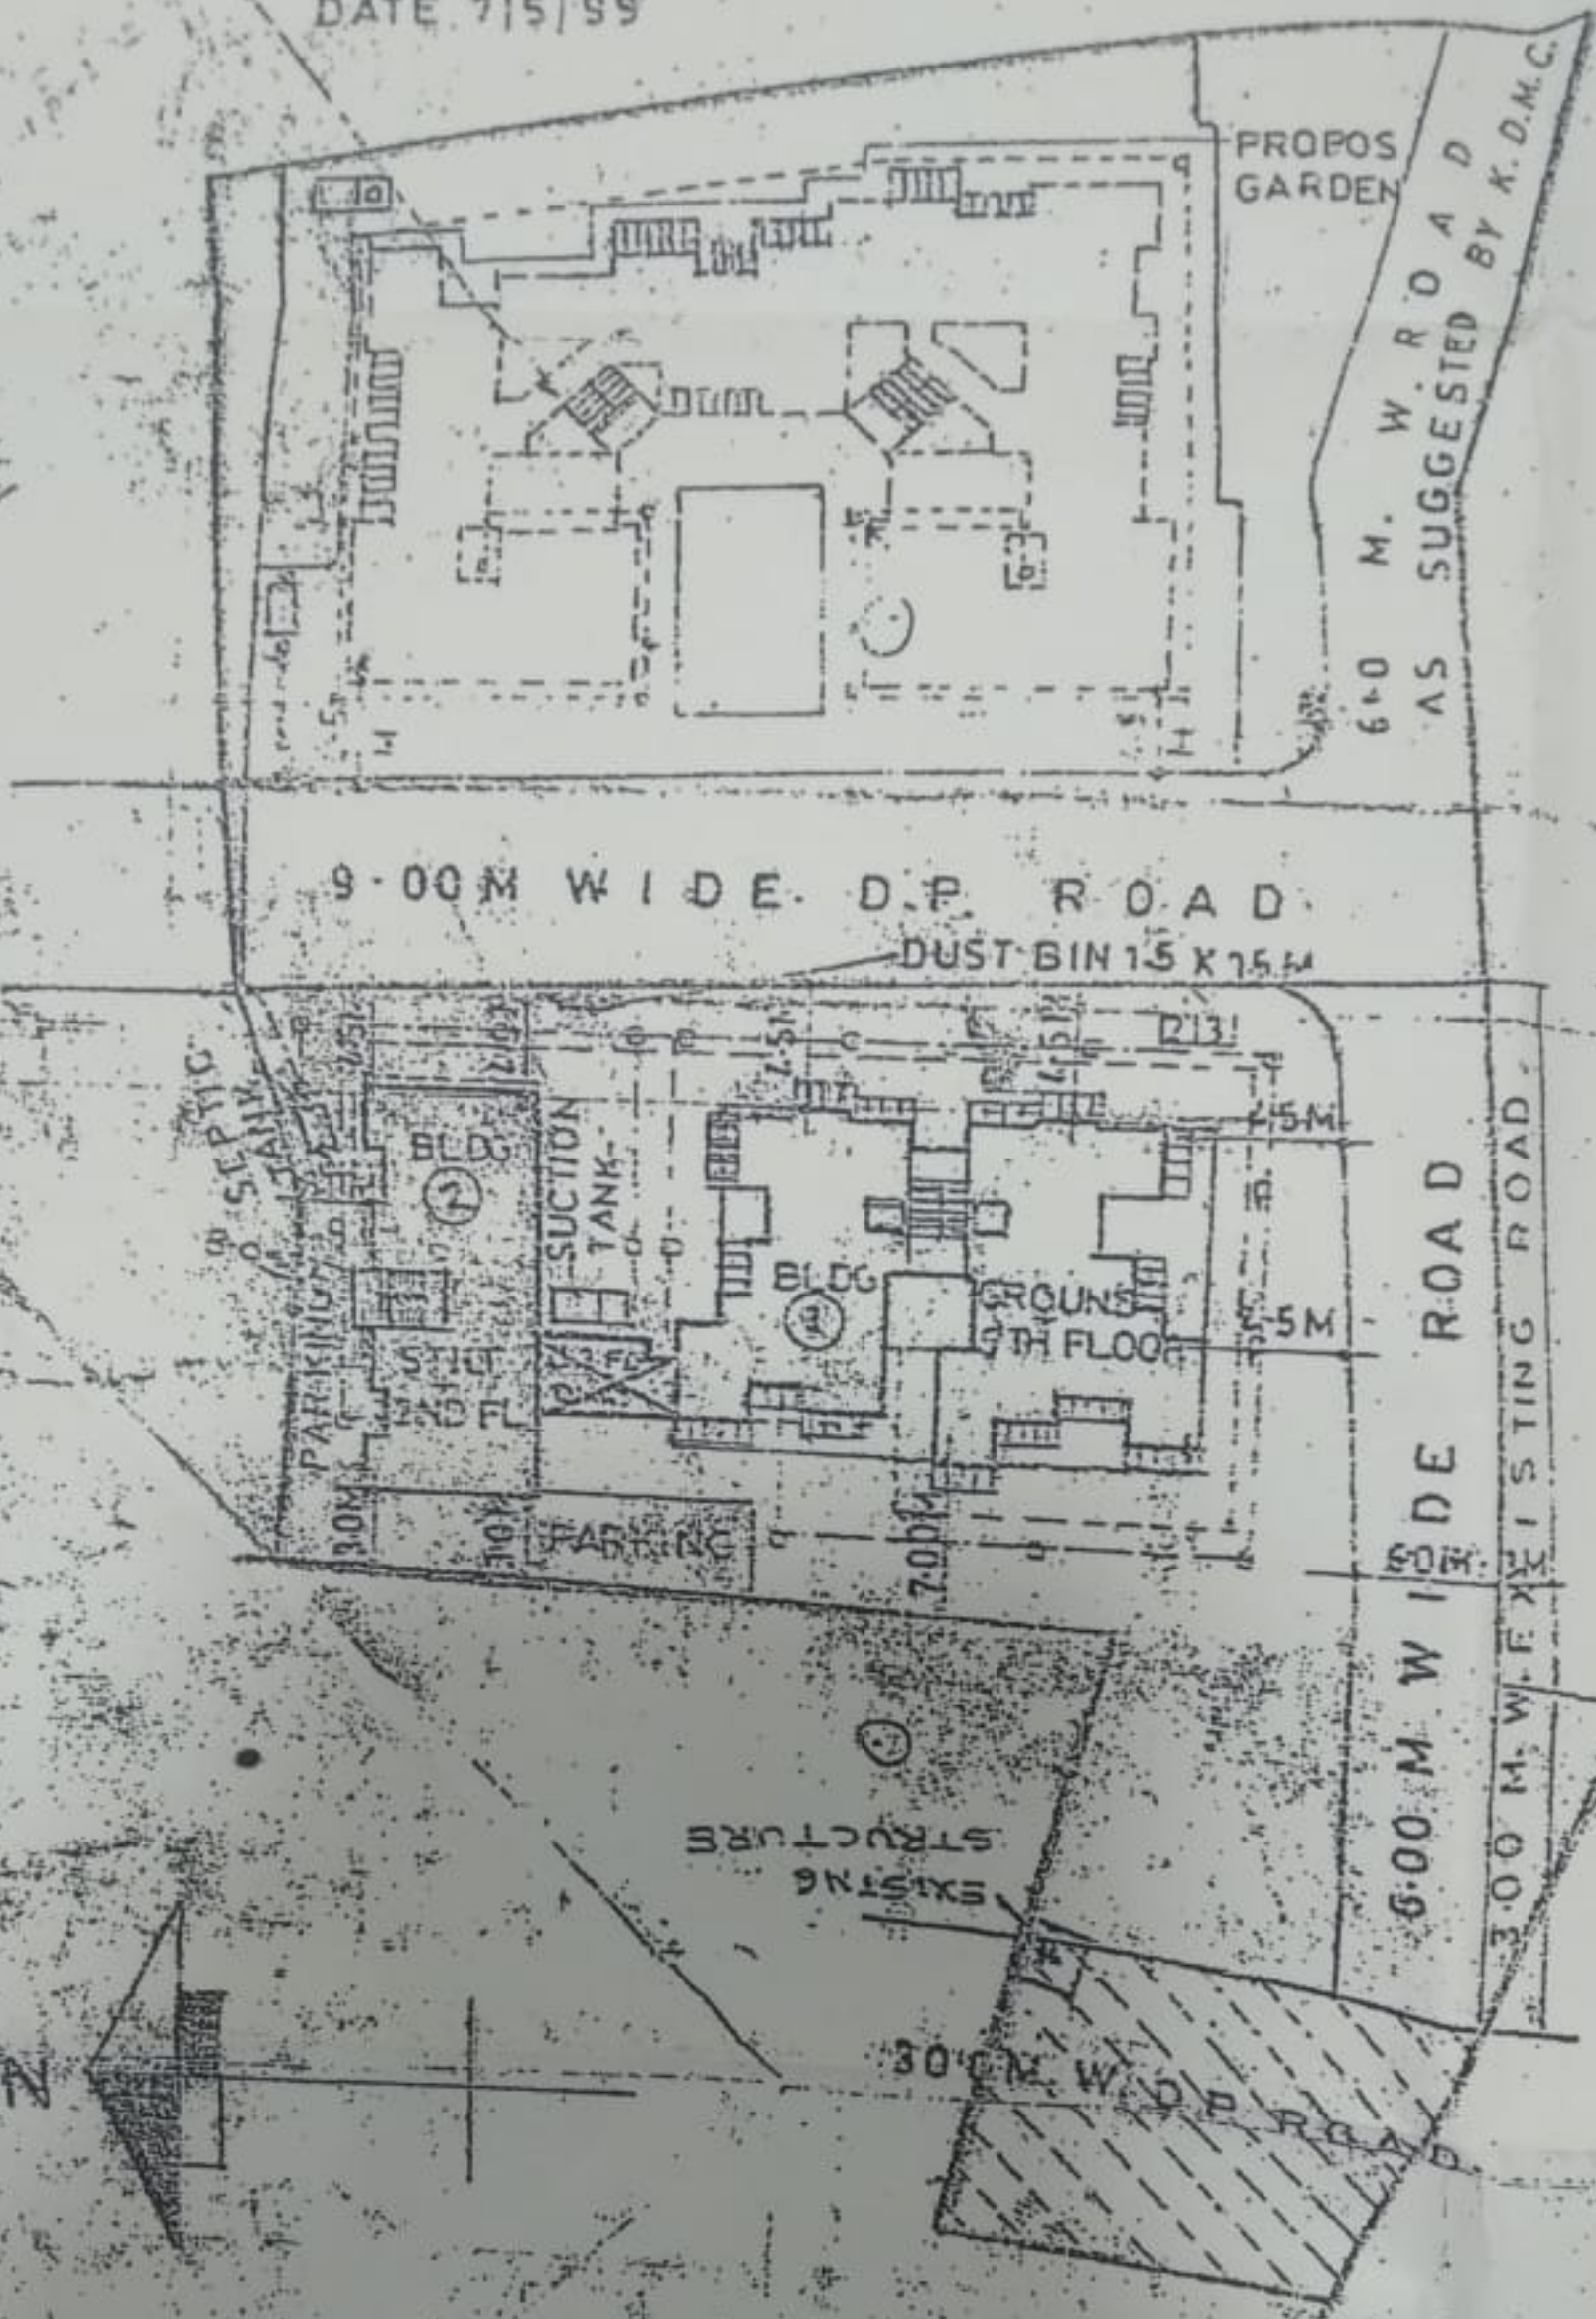


6.00 M. W. ROAD AS SUGGESTED BY K.D.M.C.

BLOCK PLAN

SCALE 1:600

PLOT AREA

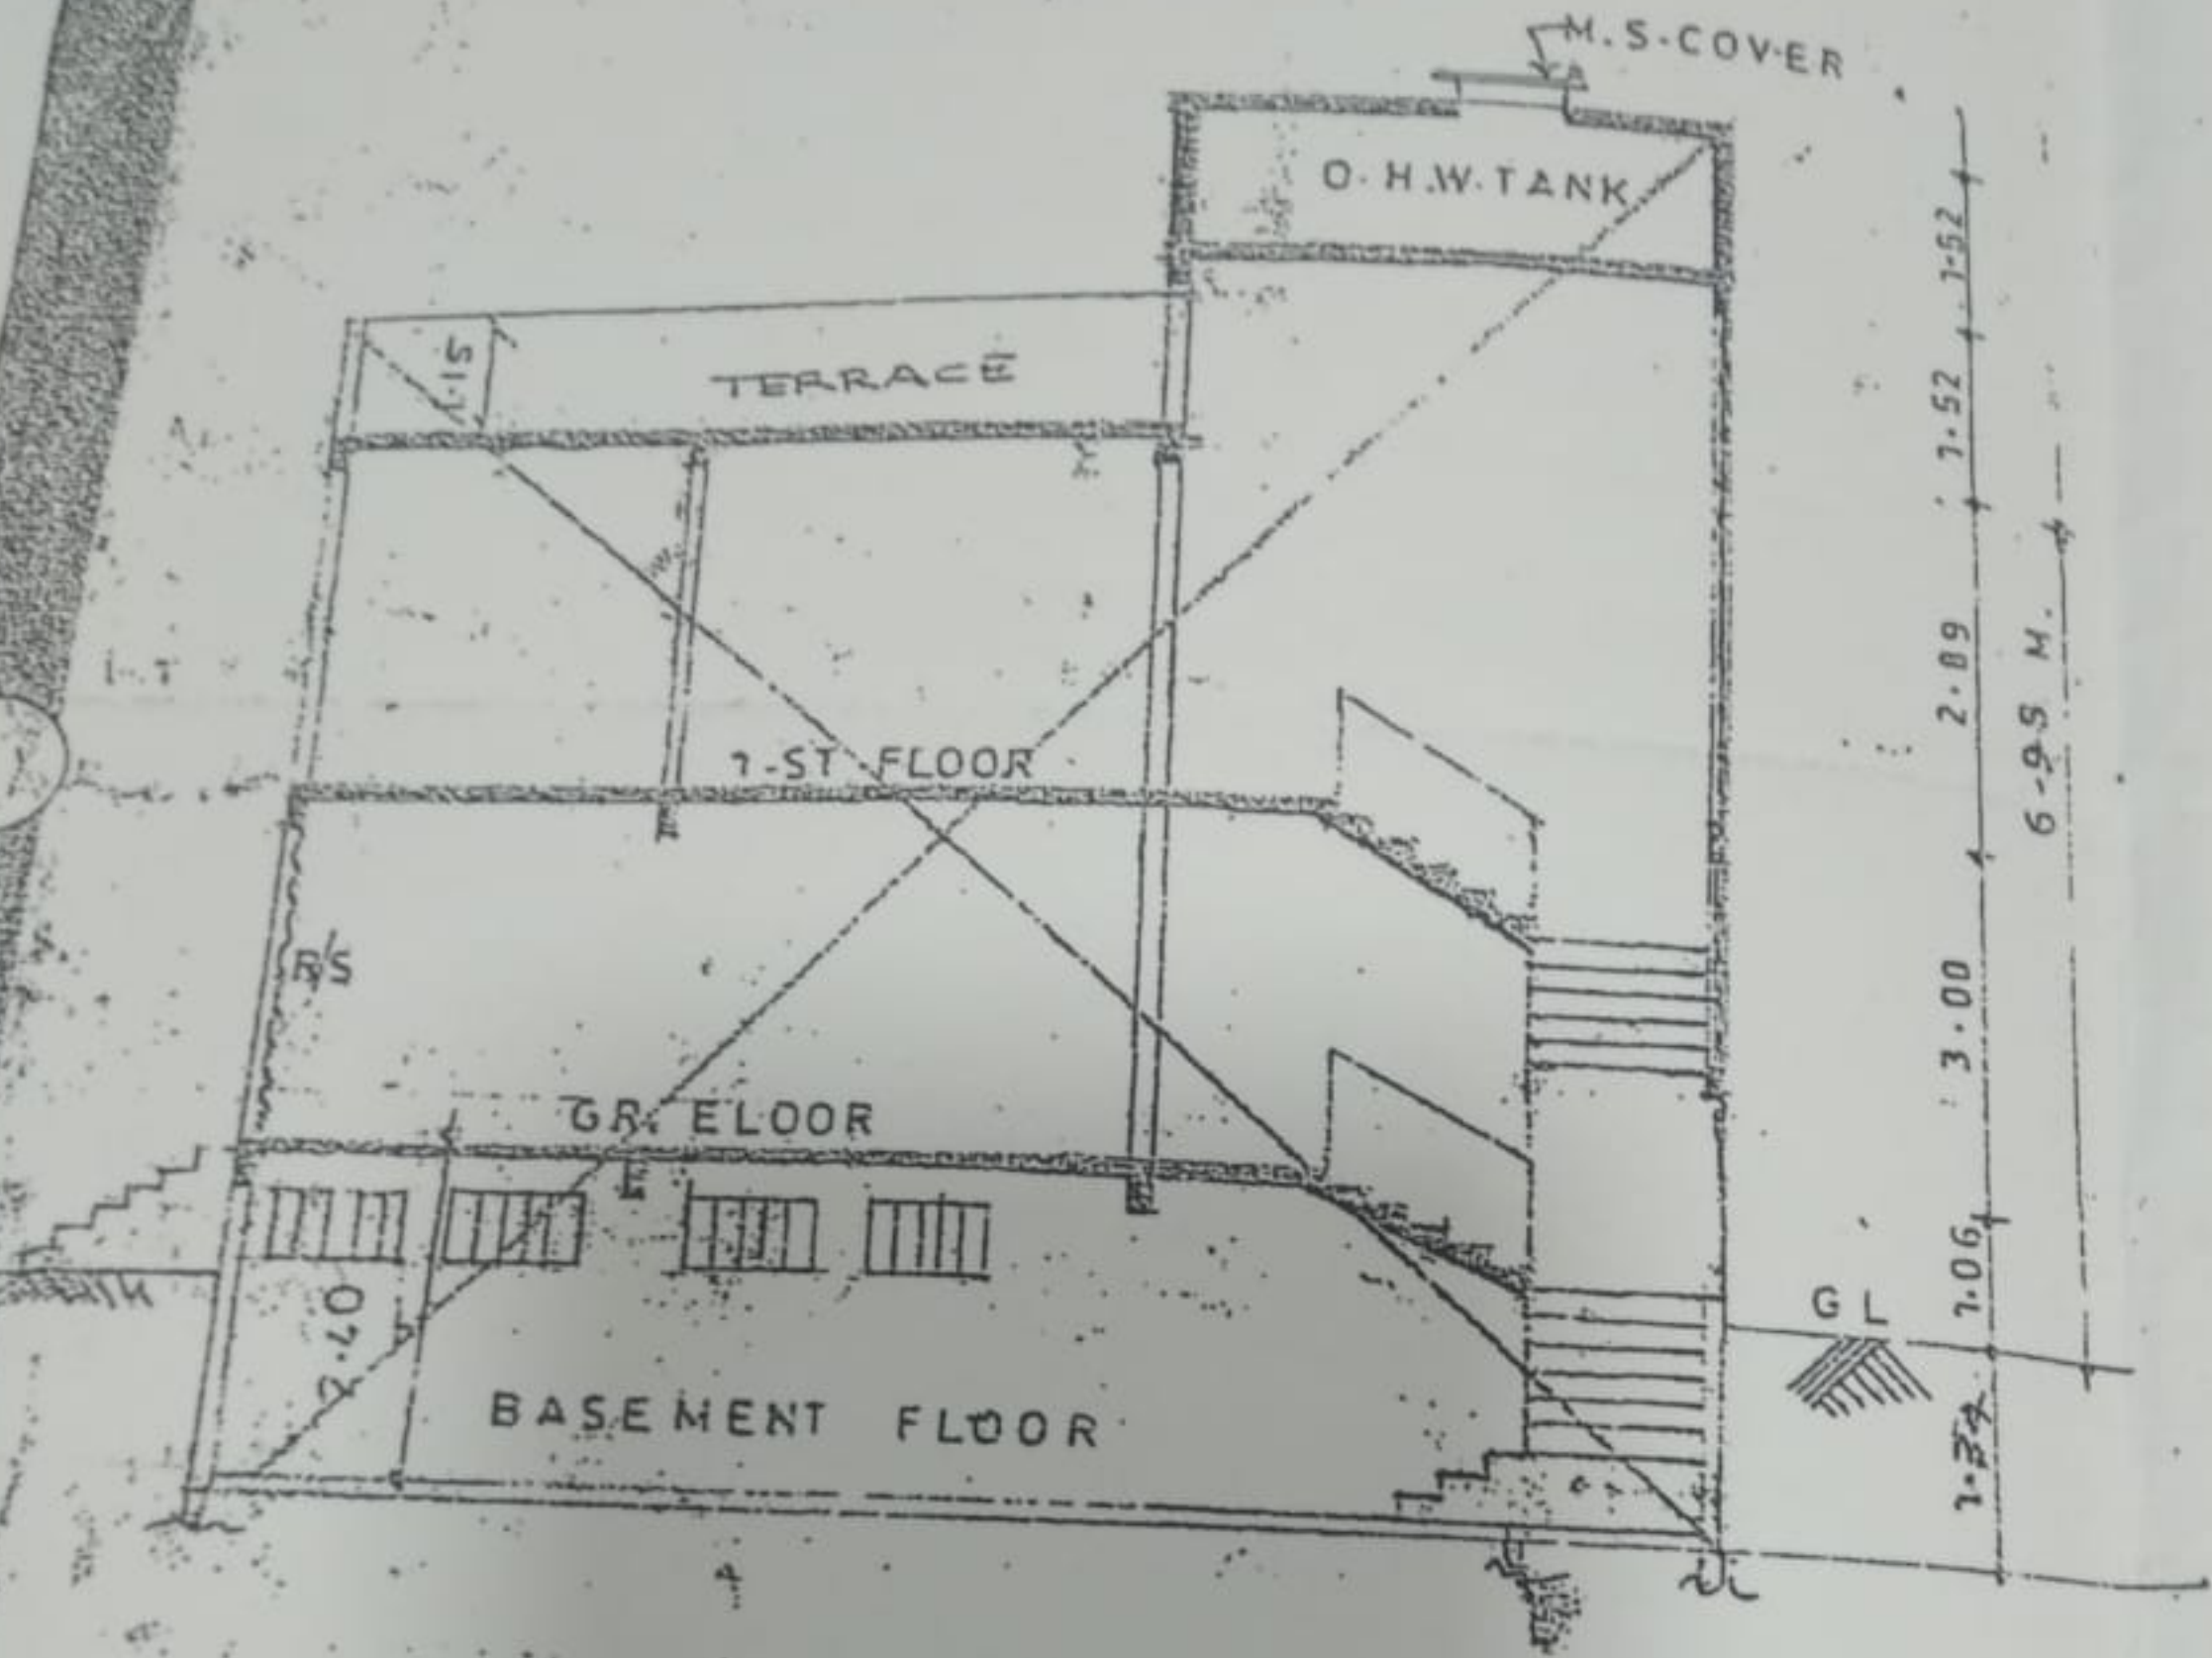

SECTION AT 'B'-'B' (BLDG NO 3)

SCALE 1:100

THIS BUILDING APPROVED BY KDMC VIDE LETTER NO
 KDMC | NRV | BP | DOM / 60-13
 DATE 7/5/99

